

GAS CYLINDERS
HAZ
ARGON UN #1006
OXYGEN UN #1072
ACETYLENE UN #1001

SUPPRESSION SYSTEM
PAINT SPRAY BOOTH

MULBERRY DRIVE



TRANSFORMER

SAND STORAGE

SAND YARD

GARBAGE

MECHANICS SHOP

FERTILIZER SHED

HAZ
CHEMICALS
PESTICIDES

HAZ
FERTILIZER

FUEL/WASHDOWN & VEHICLE BAYS

HAZ
FUEL UNLEADED - 1200 gal
& DIESEL (UN #1202)- 1200 gal

EQUIPMENT SHED

YARD

PARKING


F.D. KEY



FD ENTRY

FAAP

Maintenance & Administration Building

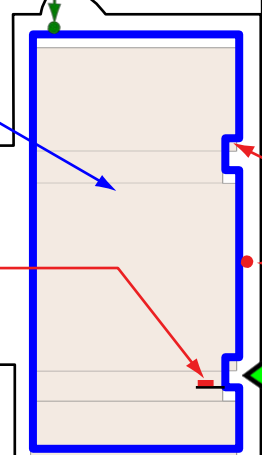

LEGEND	
	FIRE DEPARTMENT CONNECTION
	HYDRANT PRIVATE
	GAS SHUT-OFF
	FIRE ALARM ANNUNCIATOR
	FIRE DEPARTMENT KEY
	ASSEMBLY AREA

PANORAMA DRIVE

Name of Company producing FSP/PIP


Building Name (Arial Bold 14)

Drawing Name

Street Address

Site Plan

Fire Safety Plan

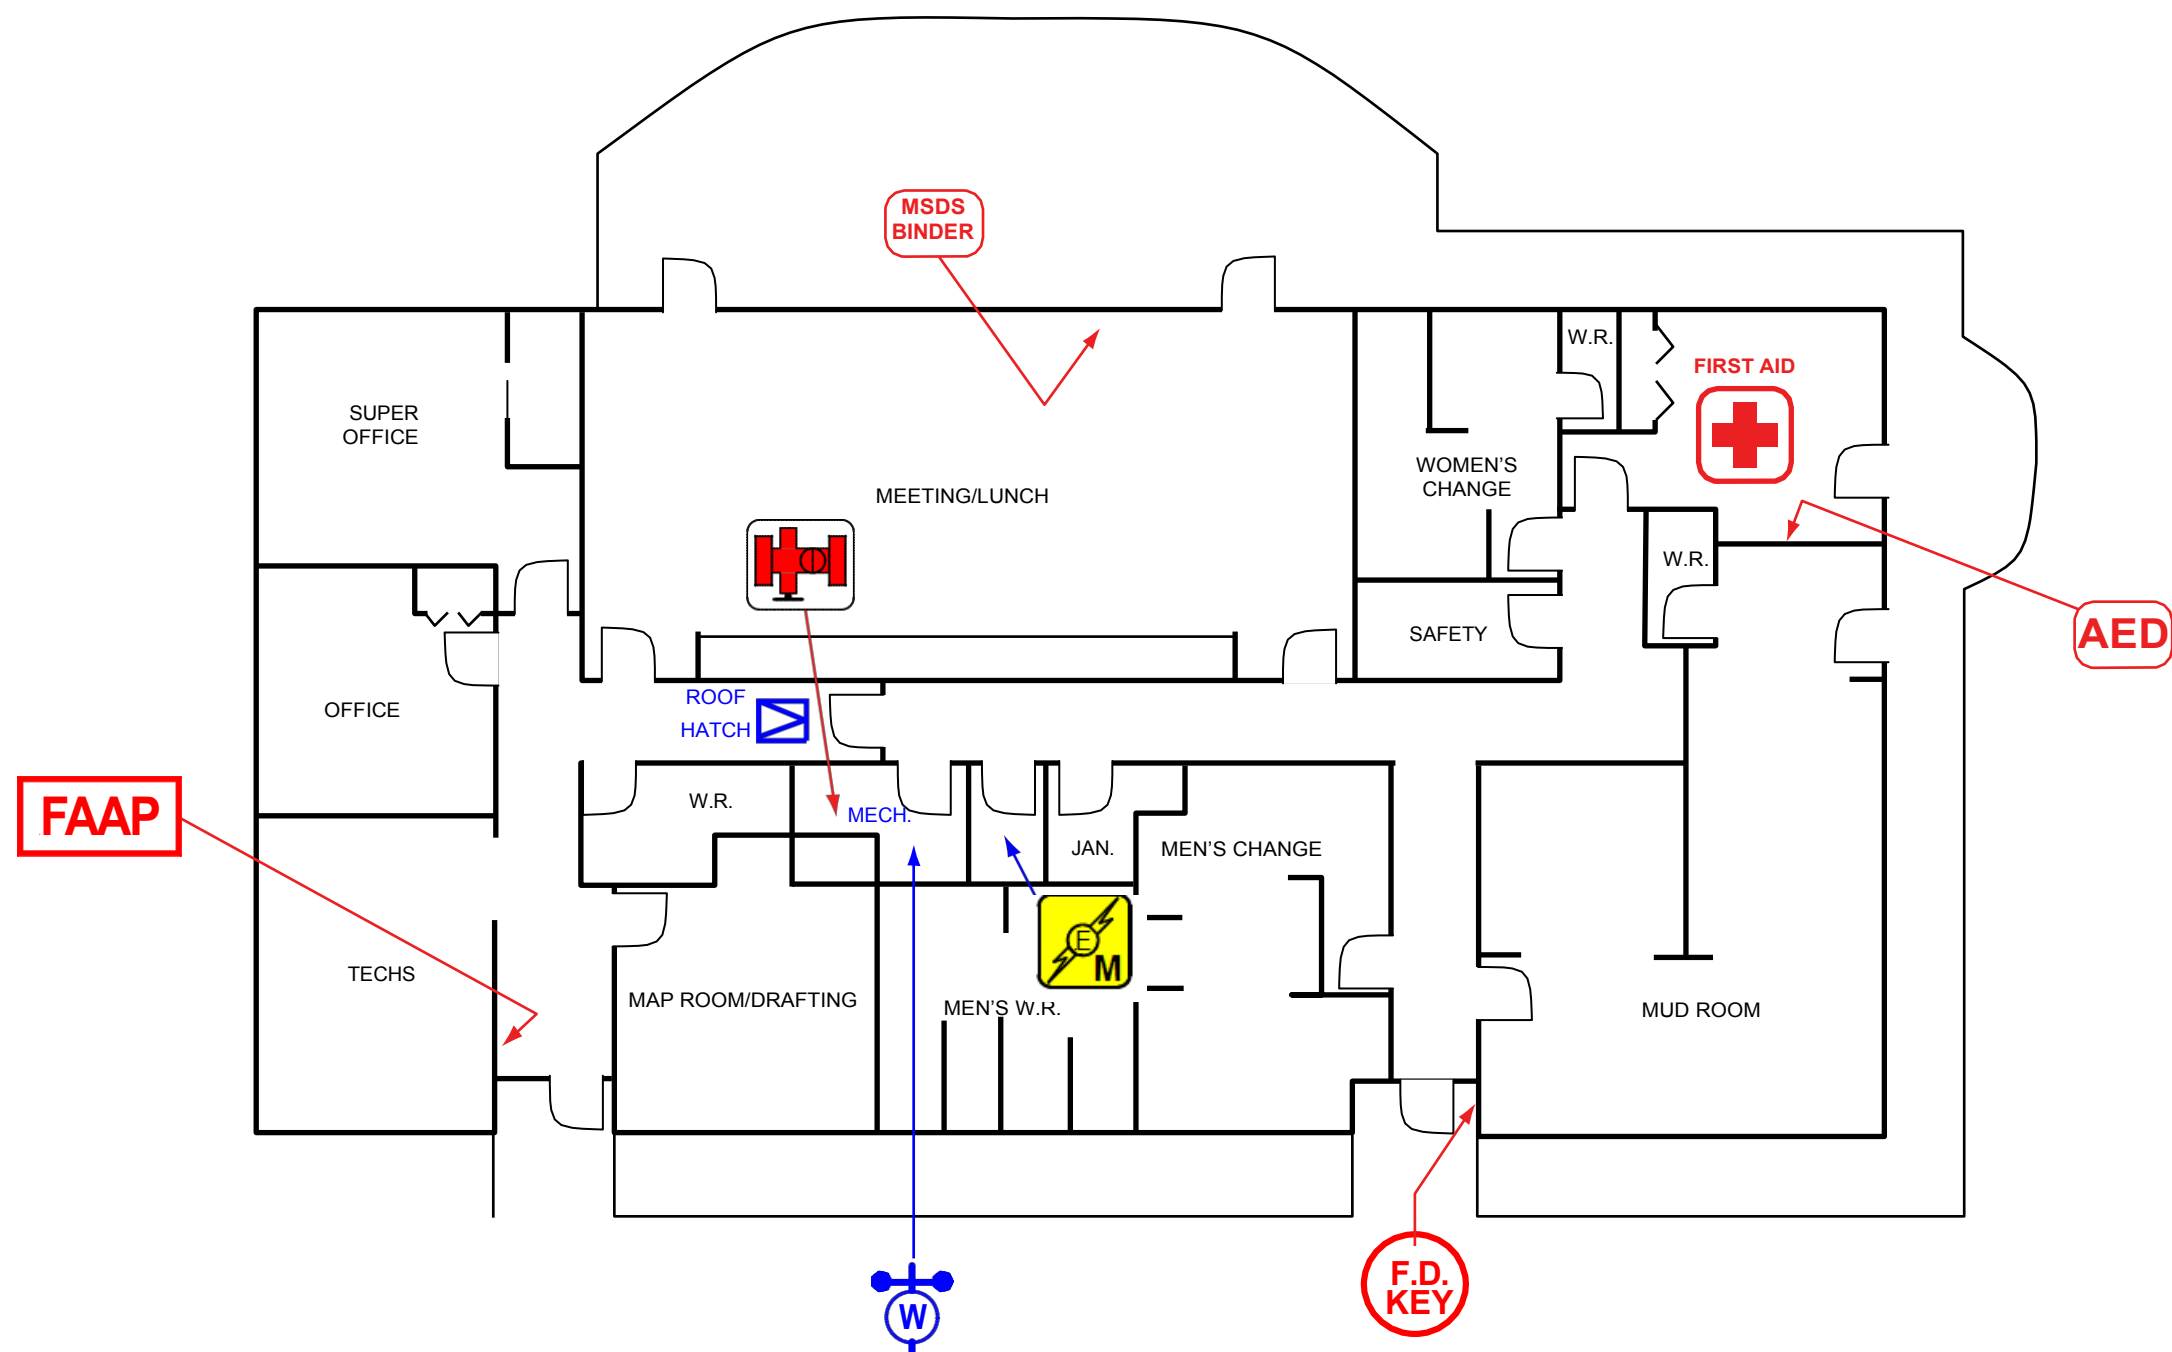

LEGEND	
	FIRE ALARM ANNUNCIATOR
	SPRINKLER VALVES
	MAIN ELECTRICAL ROOM
	WATER SHUT-OFF
	FIRE DEPARTMENT KEY

Name of Company producing FSP/PIP

Building Name (Arial Bold 14)
Drawing Name
Street Address
Floor Plan
Fire Safety Plan